


THESE LAYOUTS ARE THE PROPERTY OF CHEF SUPPLY. THESE LAYOUTS ARE FOR REFERENCE ONLY. CHEF SUPPLY IS NOT AN ENGINEERING FIRM AND DOES NOT ACCEPT THE RESPONSIBILITY OF ANY DISCREPANCIES ARISING WITH ELECTRICAL, PLUMBING, OR CODE ISSUES.

Bluegrass Brewing Company
300 West Main Street
Louisville, Kentucky

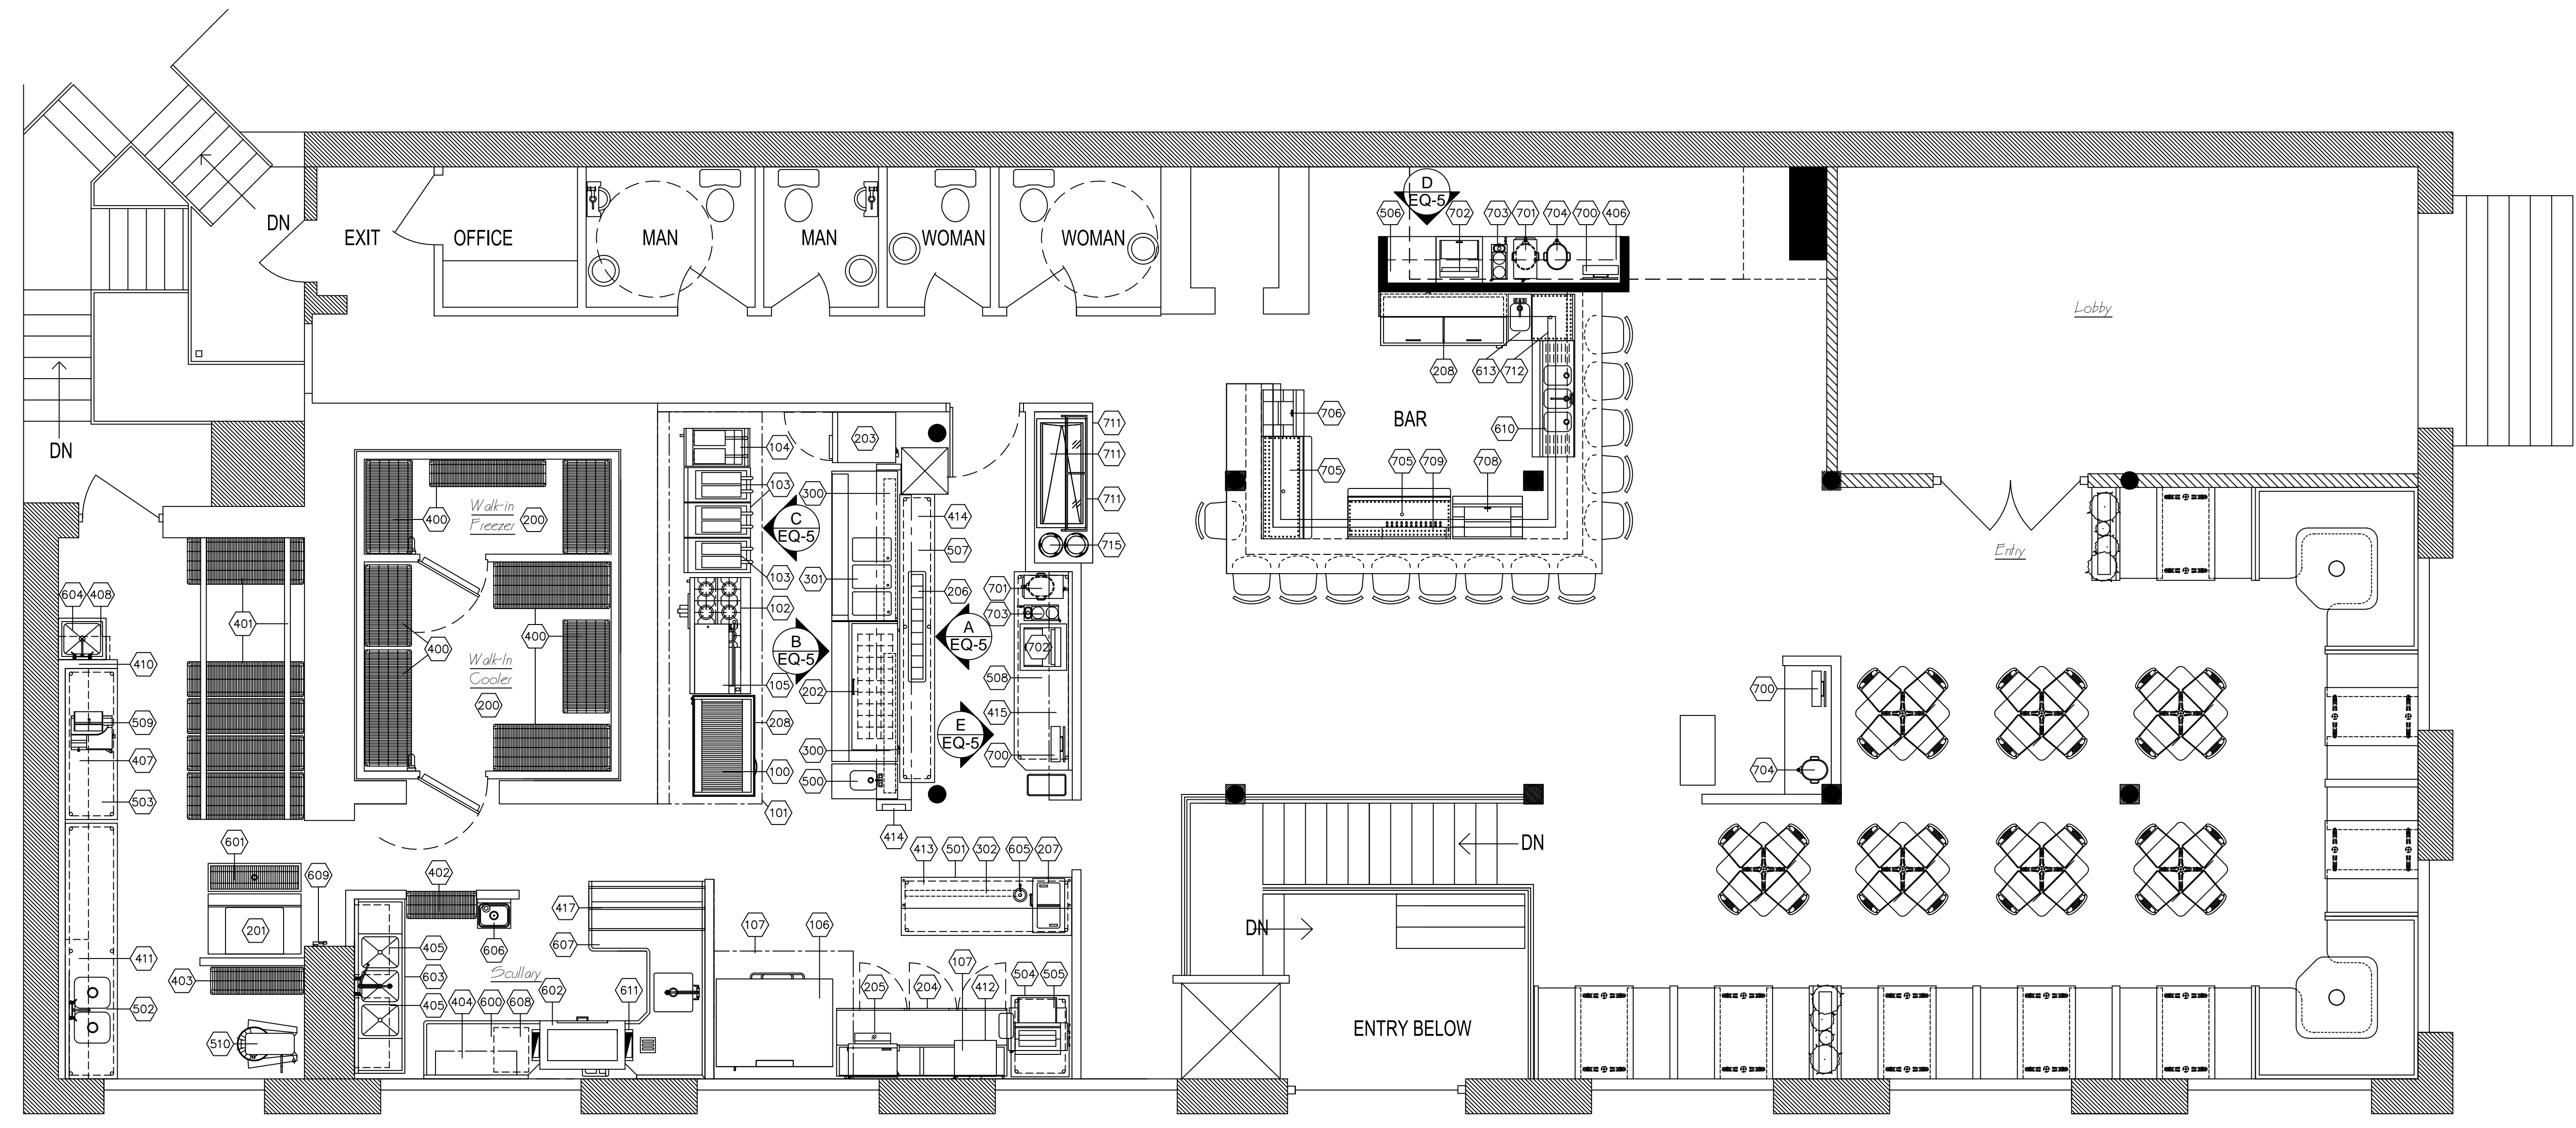

FLOOR PLAN

SCALE: 1/4" = 1'-0"

EQUIPMENT SCHEDULE		
COOKING EQUIPMENT		
100 48" CHAR GRILL	IMPERIAL	IRB-48
101 EXHAUST HOOD W/HEATED MAKE UP AIR	CHEF-AIR	CUSTOM
102 6-BURNER RANGE W/ 24" GRIDDLE ON LEFT	IMPERIAL	IR-6-G24C
103 40 LB. FRYER	IMPERIAL	IFS-40
104 75 LB. FRYER	IMPERIAL	IFS-75
105 36" SALAMANDER	IMPERIAL	ISB-36
106 DOUBLE STACK PIZZA OVEN	BLOODGET	1060 DOUBLE
107 MICROWAVE OVEN	AMANA	RCS10P
108 EXHAUST HOOD	CHEF-AIR	CUSTOM
109 GAS HOSES	DORMONT	VARIES
REFRIGERATION		
200 WALK-IN COOLER/FREEZER	ARCTIC	CUSTOM
201 ICE MACHINE W/ BIN	ICE-O-MATIC	ICE1407FA W/B120PS
202 72" WORK TOP REFRIGERATOR W/DOOR	BEVERAGE-AIR	SPF72-30M
203 SINGLE DOOR FREEZER	BEVERAGE-AIR	KF24-1AS
204 88" REFRIG. PIZZA PREP. TABLE W/DOORS	VICTORY	VP1-88
205 WALL HUNG SALAD DISPENSER	SILVER KING	SK25B-DB
206 DROP IN ICE PAN	FABRICATED	CUSTOM
207 ICE CREAM FREEZER	SILVER KING	SKDI
208 50" BOTTLE BOX	BEVERAGE-AIR	DW49-B-29
209 64" BOTTLE BOX	BEVERAGE-AIR	DW64-B-29
210 UNDERCOUNTER REFRIGERATOR	BEVERAGE-AIR	UCR-34
211 REFRIGERATED EQUIPMENT BASE	---	---
212 SPARE	---	---
WARMING EQUIPMENT		
300 72" HEAT LAMPS	HATCO	GRAH-72D
301 3 WELL STEAM TABLE W/DRAINS & WATER	FABRICATED	CUSTOM
302 60" HEAT LAMP	HATCO	GRAH-60
303 SPARE	---	---

EQUIPMENT SCHEDULE		
SHELVING		
400 COOLER/FREEZER SHELVING	NEXEL	EPOXY
401 HIGH DENSITY WIRE SHELVING-DRY STORAGE	EAGLE	EPOXY
402 WIRE SHELVING (4 SHELVES 4 POSTS)	NEXEL	EPOXY
403 WIRE SHELVING (4 SHELVES 4 POSTS)	NEXEL	EPOXY
404 SLANT RACK	FABRICATED	EPOXY
405 WIRE SHELVING WALL MOUNTED	NEXEL	EPOXY W/WALL BRACKETS
406 120" WALL SHELF-STAINLESS STEEL	TURBO AIR	TSWS-12120
407 60" WALL SHELF-STAINLESS STEEL	TURBO AIR	TSWS-1260
408 24" WALL SHELF-STAINLESS STEEL	TURBO AIR	TSWS-1224
409 48" WALL SHELF-STAINLESS STEEL	TURBO AIR	TSWS-1248
410 60" WALL SHELF-STAINLESS STEEL	TURBO AIR	TSWS-1260
411 72" WALL SHELF-STAINLESS STEEL	TURBO AIR	TSWS-1272
412 MICROWAVE SHELF	ADVANCE	MS1824
413 18" X 88" DOUBLE TIER S/S OVERSHELF	FABRICATED	CUSTOM
414 18" X 178" DOUBLE TIER S/S OVERSHELF	FABRICATED	CUSTOM
415 117" WALL SHELF-STAINLESS STEEL	FABRICATED	CUSTOM
416 SPARE	---	---
417 DISH SORTING SHELF	ADVANCE	DTA-79-60
418 SPARE	---	---
419 SPARE	---	---
420 SPARE	---	---
421 SPARE	---	---

EQUIPMENT SCHEDULE		
PREPARATION EQUIPMENT		
500 18"x30" S/S WORK TABLE W/HAND SINK	FABRICATED	CUSTOM
501 30"x76" S/S WORK TABLE	FABRICATED	CUSTOM
502 27"x132" S/S WORK TABLE W/2 SINK BOWLS	FABRICATED	CUSTOM
503 27"x60" S/S WORK TABLE	FABRICATED	CUSTOM
504 42"x30" S/S WORK TABLE	FABRICATED	CUSTOM
505 DOUGH ROLLER	ACME	MR511
506 BEVERAGE COUNTER	FABRICATED	CUSTOM
507 WAITRESS PLATE STATION TABLE	FABRICATED	CUSTOM
508 BEVERAGE COUNTER	FABRICATED	CUSTOM
509 SLICER	BERKEL	827A
510 40 QT. MIXER	BERKEL	PM40
511 SPARE	---	---
512 SPARE	---	---
513 SPARE	---	---
514 SPARE	---	---
SINKS & CLEAN AREAS		
600 CLEAN DISHTABLE	ADVANCE	DTA-79-60R
601 48" FLOOR TROUGH	ADVANCE	FRG-48
602 DISHMACHINE	ADC	44
603 3-COMPARTMENT SINK W/PRERINSE	TURBO-AIR	TSA-3-D1
604 MOP SINK W/FAUCET, HOSE & MOP HOLDERS	ADVANCE	9-OP-40
605 DIPPER WELL ASSEMBLY	FISHER	3041
606 HAND SINK	TURBO-AIR	TSS-1-H
607 SOLED DISHTABLE	ADVANCE	CUSTOM
608 BOOSTER HEATER	HUBBELL	J1927
609 WATER FILTER	ICE-O-MATIC	IF-2
610 THREE COMPARTMENT UNDERBAR SINK	SUPREME METAL	SLB-53C
611 PAINT LEG DUCT	FABRICATED	CUSTOM
612 GREASE TRAP	BY OWNER	BY OWNER
613 HAND SINK	SUPREME METAL	SC-12-TS-S
614 GLASS WASHER	CHAMPION	CG

EQUIPMENT SCHEDULE		
SERVING EQUIPMENT		
700 P.O.S.	BY OWNER	BY OWNER
701 COFFEE BREWER/DISPENSER	VENDOR	VENDOR
702 POST MIX W/ICE CHEST	VENDOR	VENDOR
703 ICE TEA BREWER/DISPENSER	VENDOR	VENDOR
704 TEA DISPENSERS	VENDOR	VENDOR
705 53" GLASS RACK W/ S/S DRAIN TOP	FABRICATED	CUSTOM
706 24" ICE CHEST W/7 CIRCUIT COLD PLATE	SUPREME METAL	CRI-16-24-7
707 48" GLASS RACK W/ S/S DRAIN TOP	FABRICATED	CUSTOM
708 36" ICE CHEST W/7 CIRCUIT COLD PLATE	SUPREME METAL	CRI-16-36-7
709 DRAFT BEER TAPS	BY OWNER	BY OTHERS
710 SPARE	---	---
711 SALAD BAR W/ SNEEZE GUARD	FABRICATED	CUSTOM
712 CORNER FILLER PANEL	FABRICATED	CUSTOM
713 SPARE	---	---
714 SPARE	---	---
715 PLATE DISPENSERS	APW	TBD
716 24" GLASS RACK W/ S/S DRAIN TOP	FABRICATED	CUSTOM
717 SPARE	---	---
SEATING		
800 48" SINGLE BOOTH	ATS	TBD
801 48" DOUBLE BOOTH	ATS	TBD
802 30" SINGLE BOOTH	ATS	TBD
803 30" DOUBLE BOOTH	ATS	TBD
804 SETTEE'S	ATS	TBD
805 WAITING BENCHES	ATS	TBD
806 BAR STOOLS	ATS	TBD
807 CHAIRS	ATS	TBD
808 TABLE TOPS 36" X 36"	ATS	TBD
809 TABLE TOPS 30" X 30"	ATS	TBD
810 TABLE TOPS 30" X 48"	ATS	TBD
811 TABLE TOPS 30" DIA.	ATS	TBD
812 TABLE TOPS 24" X 30"	ATS	TBD
813 CORNER BOOTH	ATS	TBD
814 CORNER BOOTH TABLE TOP	ATS	TBD
815 SPARE	---	---

PROPOSED FLOOR PLAN

number: BBC MAIN ST.DWG
date: January 13, 2010
revised:
by: Scott W. Rudd
checked:
by:

drawing no.
EQ-1

sheet no.
1 of 5